


**FOUNDATION PLAN FOR
ELECTRONIC AND COMPUTERISED UNIVERSAL TESTING MACHINE**

TUE-C-100

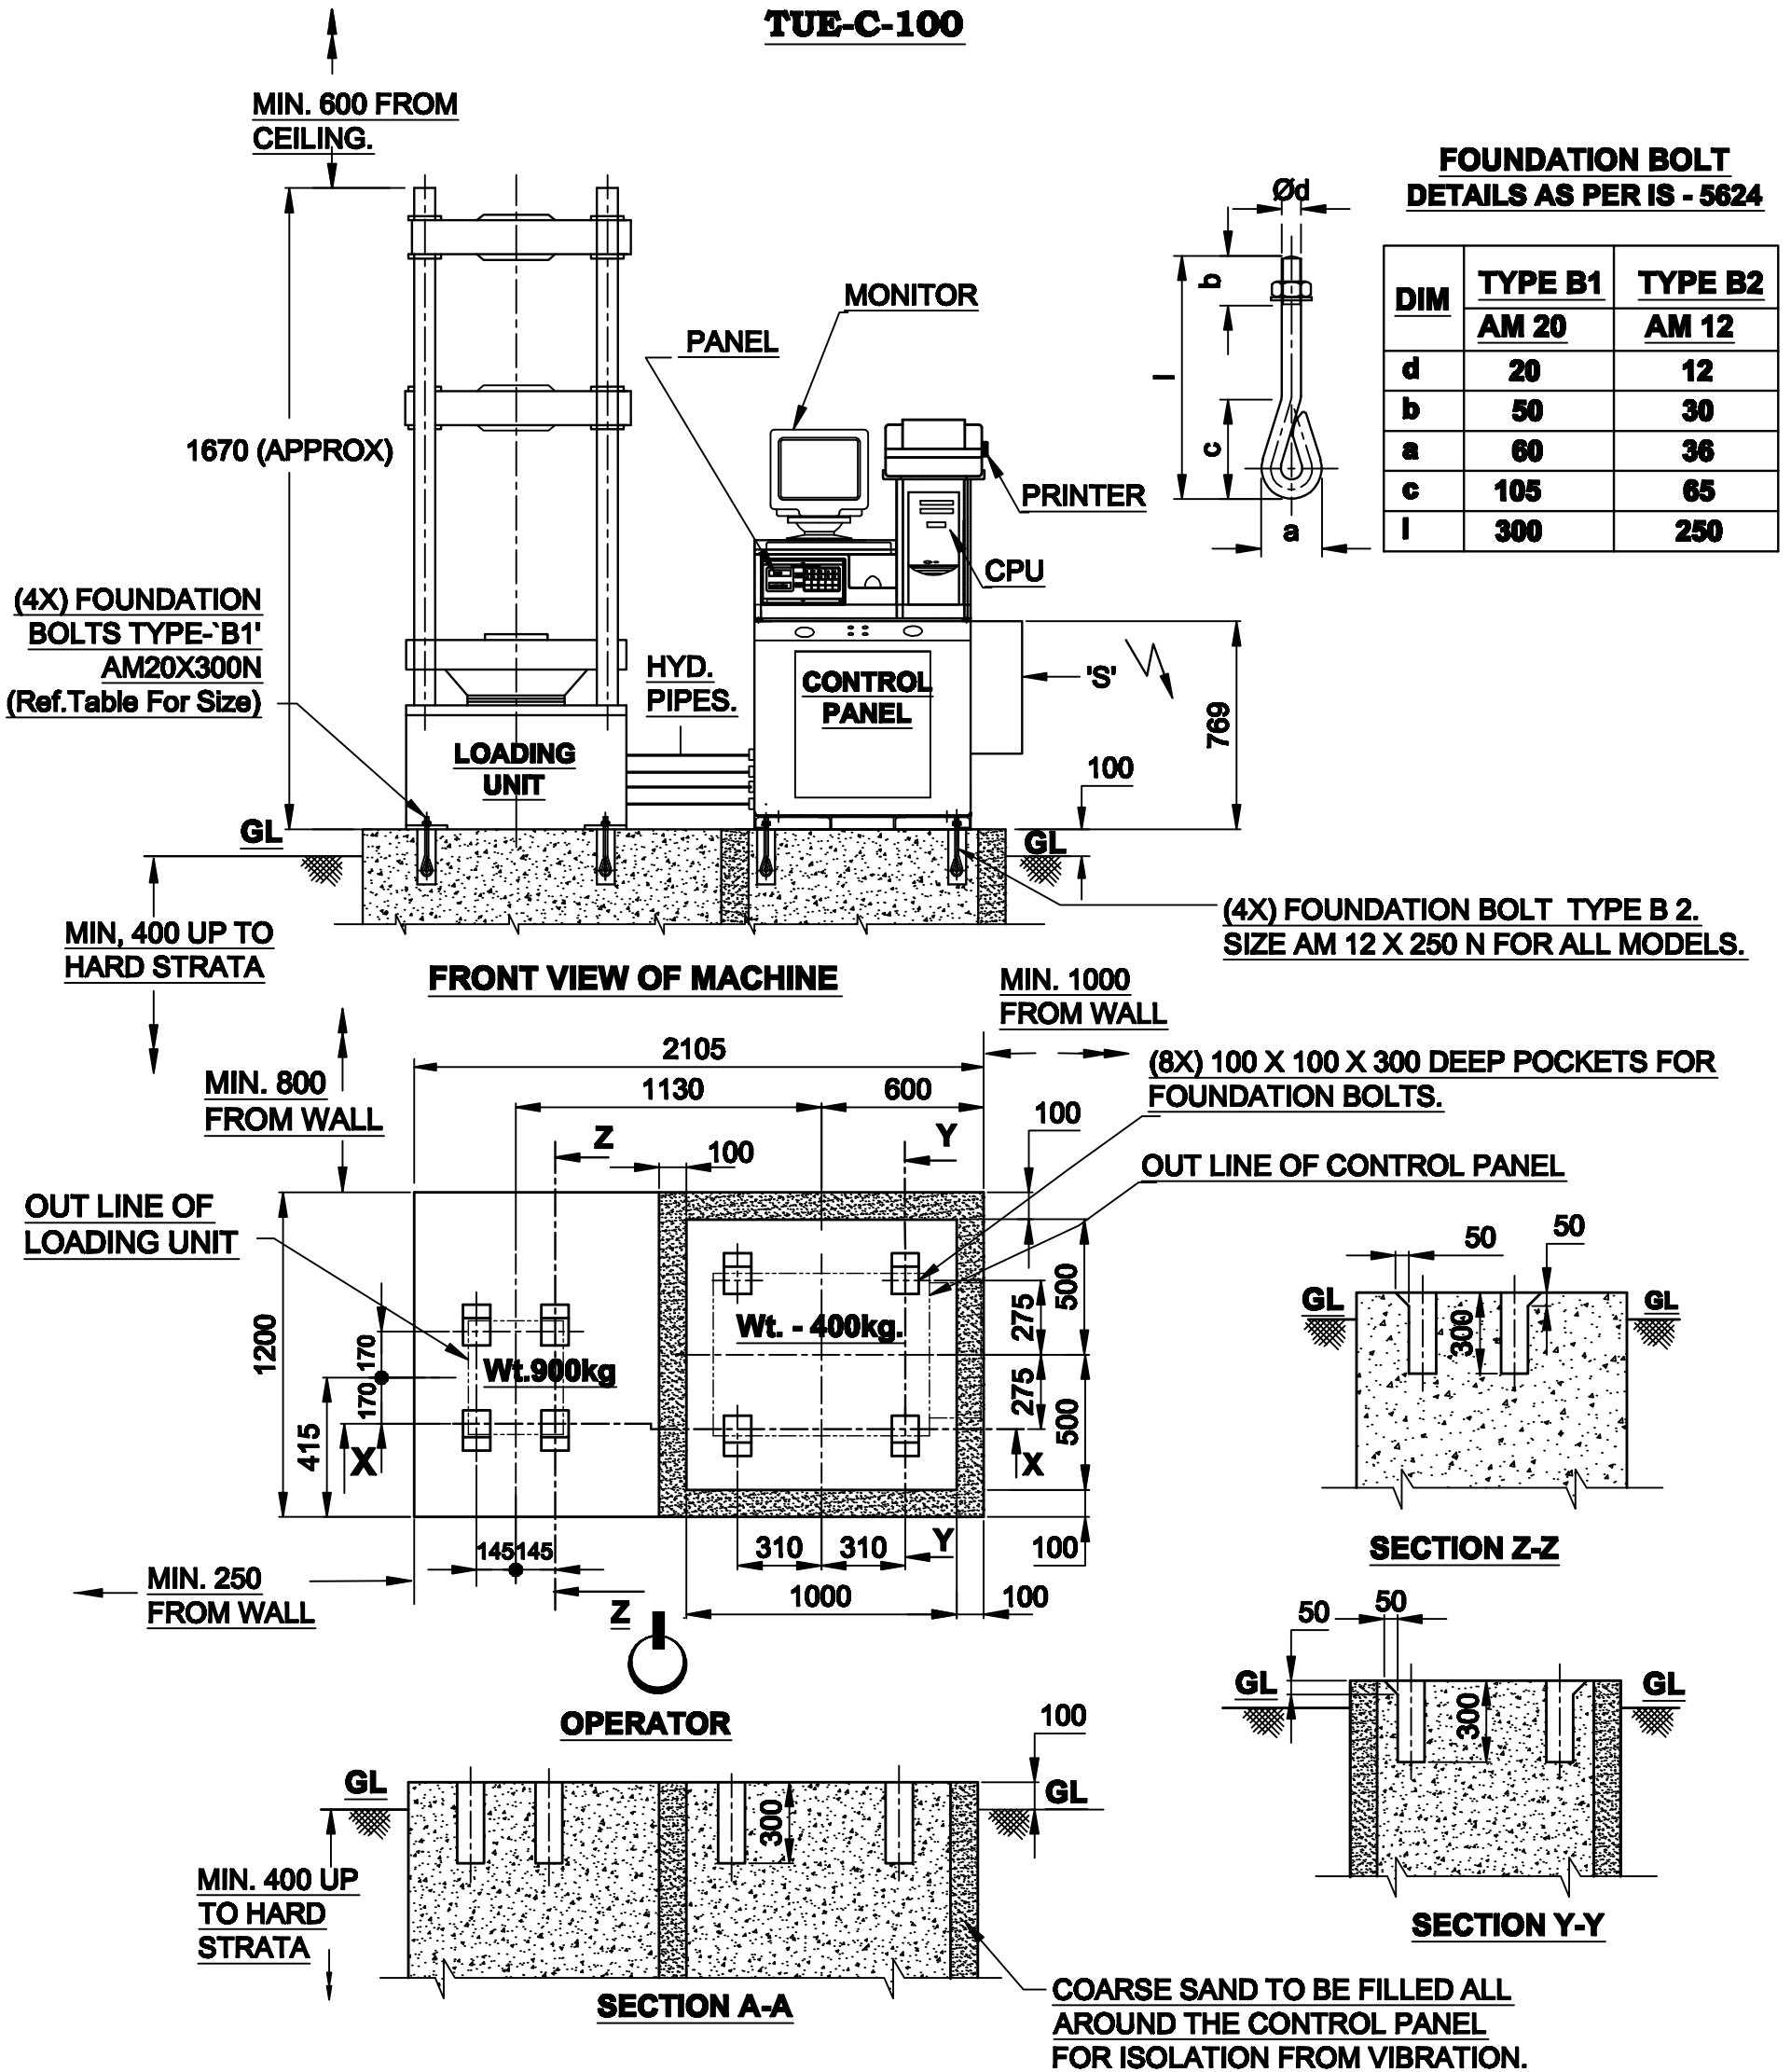

**NOTE :-1) ALL DIMENSIONS ARE IN mm.
2) 'S' ELECTRIC SUPPLY POINT LOCATION.
(3 PHASE, 440 V, 50 CYCLE, A.C.)**

DRG. No. TUE-C-100-FP-01

DATE- 12-03-10

**FINE SPAVY ASSOCIATES & ENGINEERS PVT. LTD.
C-45/2, M.I.D.C. MIRAJ.**

DRN. BY- AMP

CHKD. BY-